


SERVICE HALLWAY


PREFUNCTION

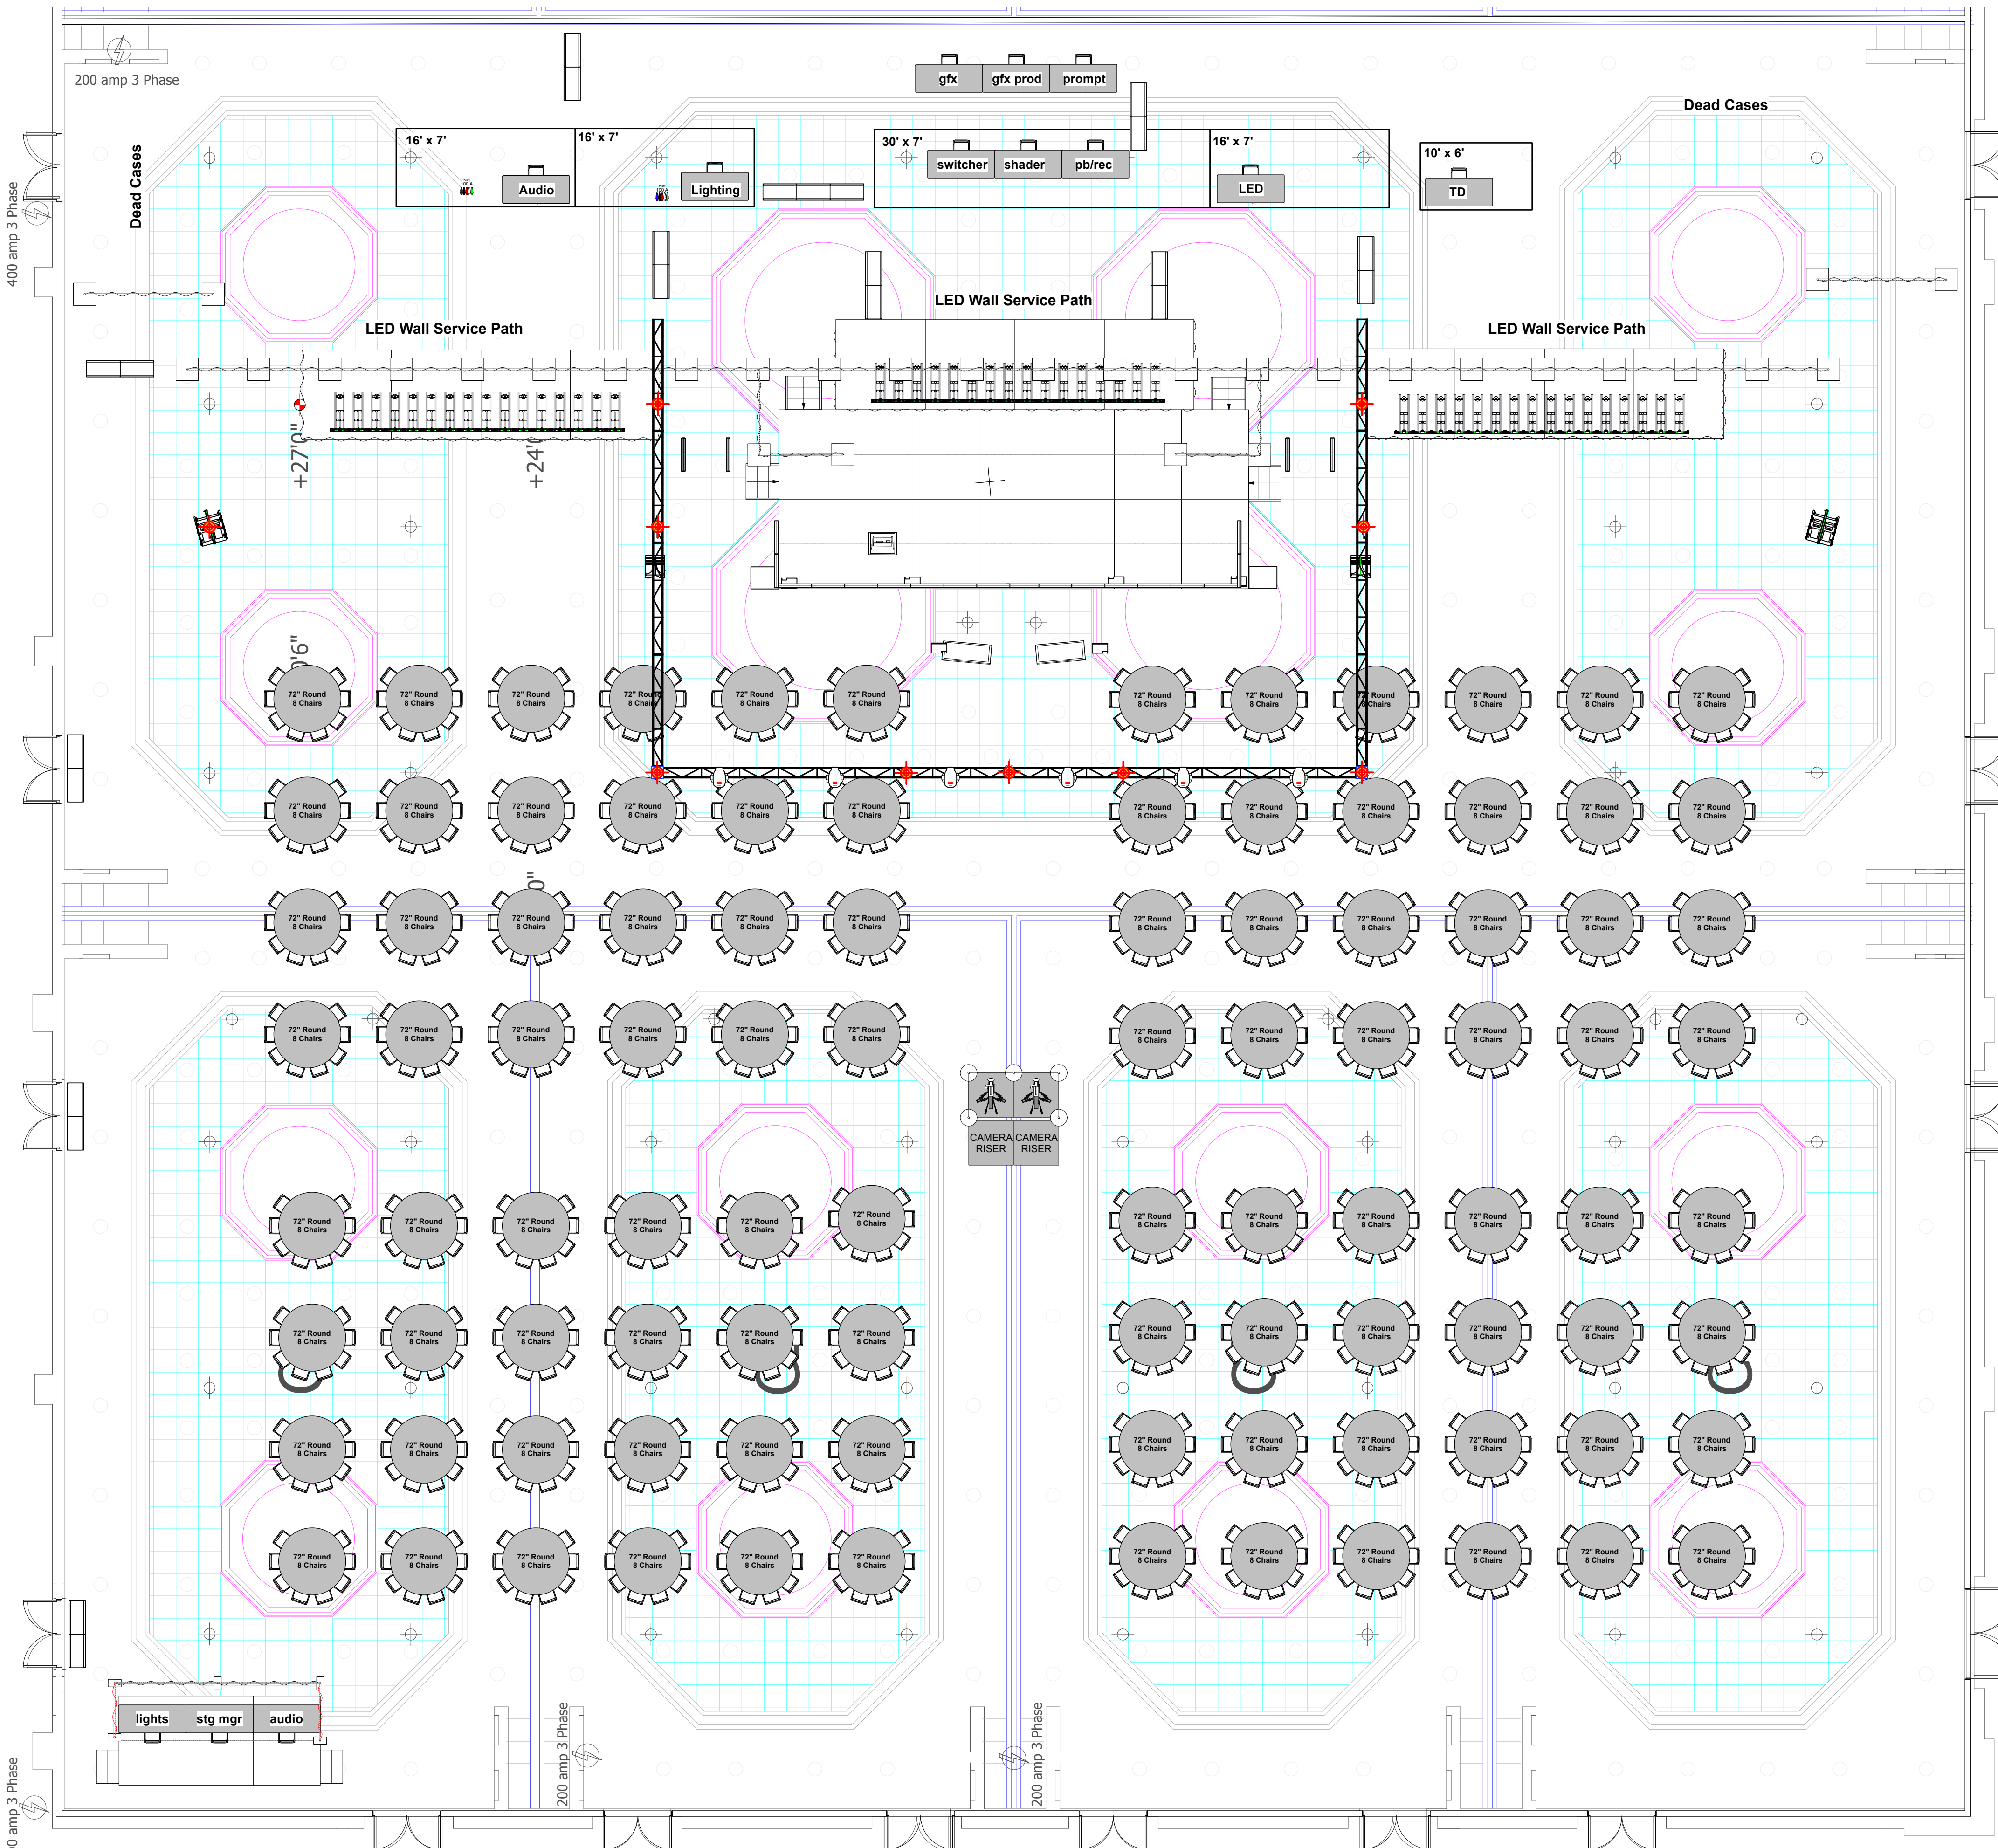

1 Ground Plan
 Scale: 1/8" = 1'-0"

OUTBACK MPS Conference	
Ground Plan	Date : 6/17/26
Sheraton Dallas Lone Star Ballroom	Scale : 1/8" = 1'-0"
Technical Director : Chris Caizzo	Sht-1
Executive Producer : Joe Mertz	
OF	
9	

SERVICE HALLWAY

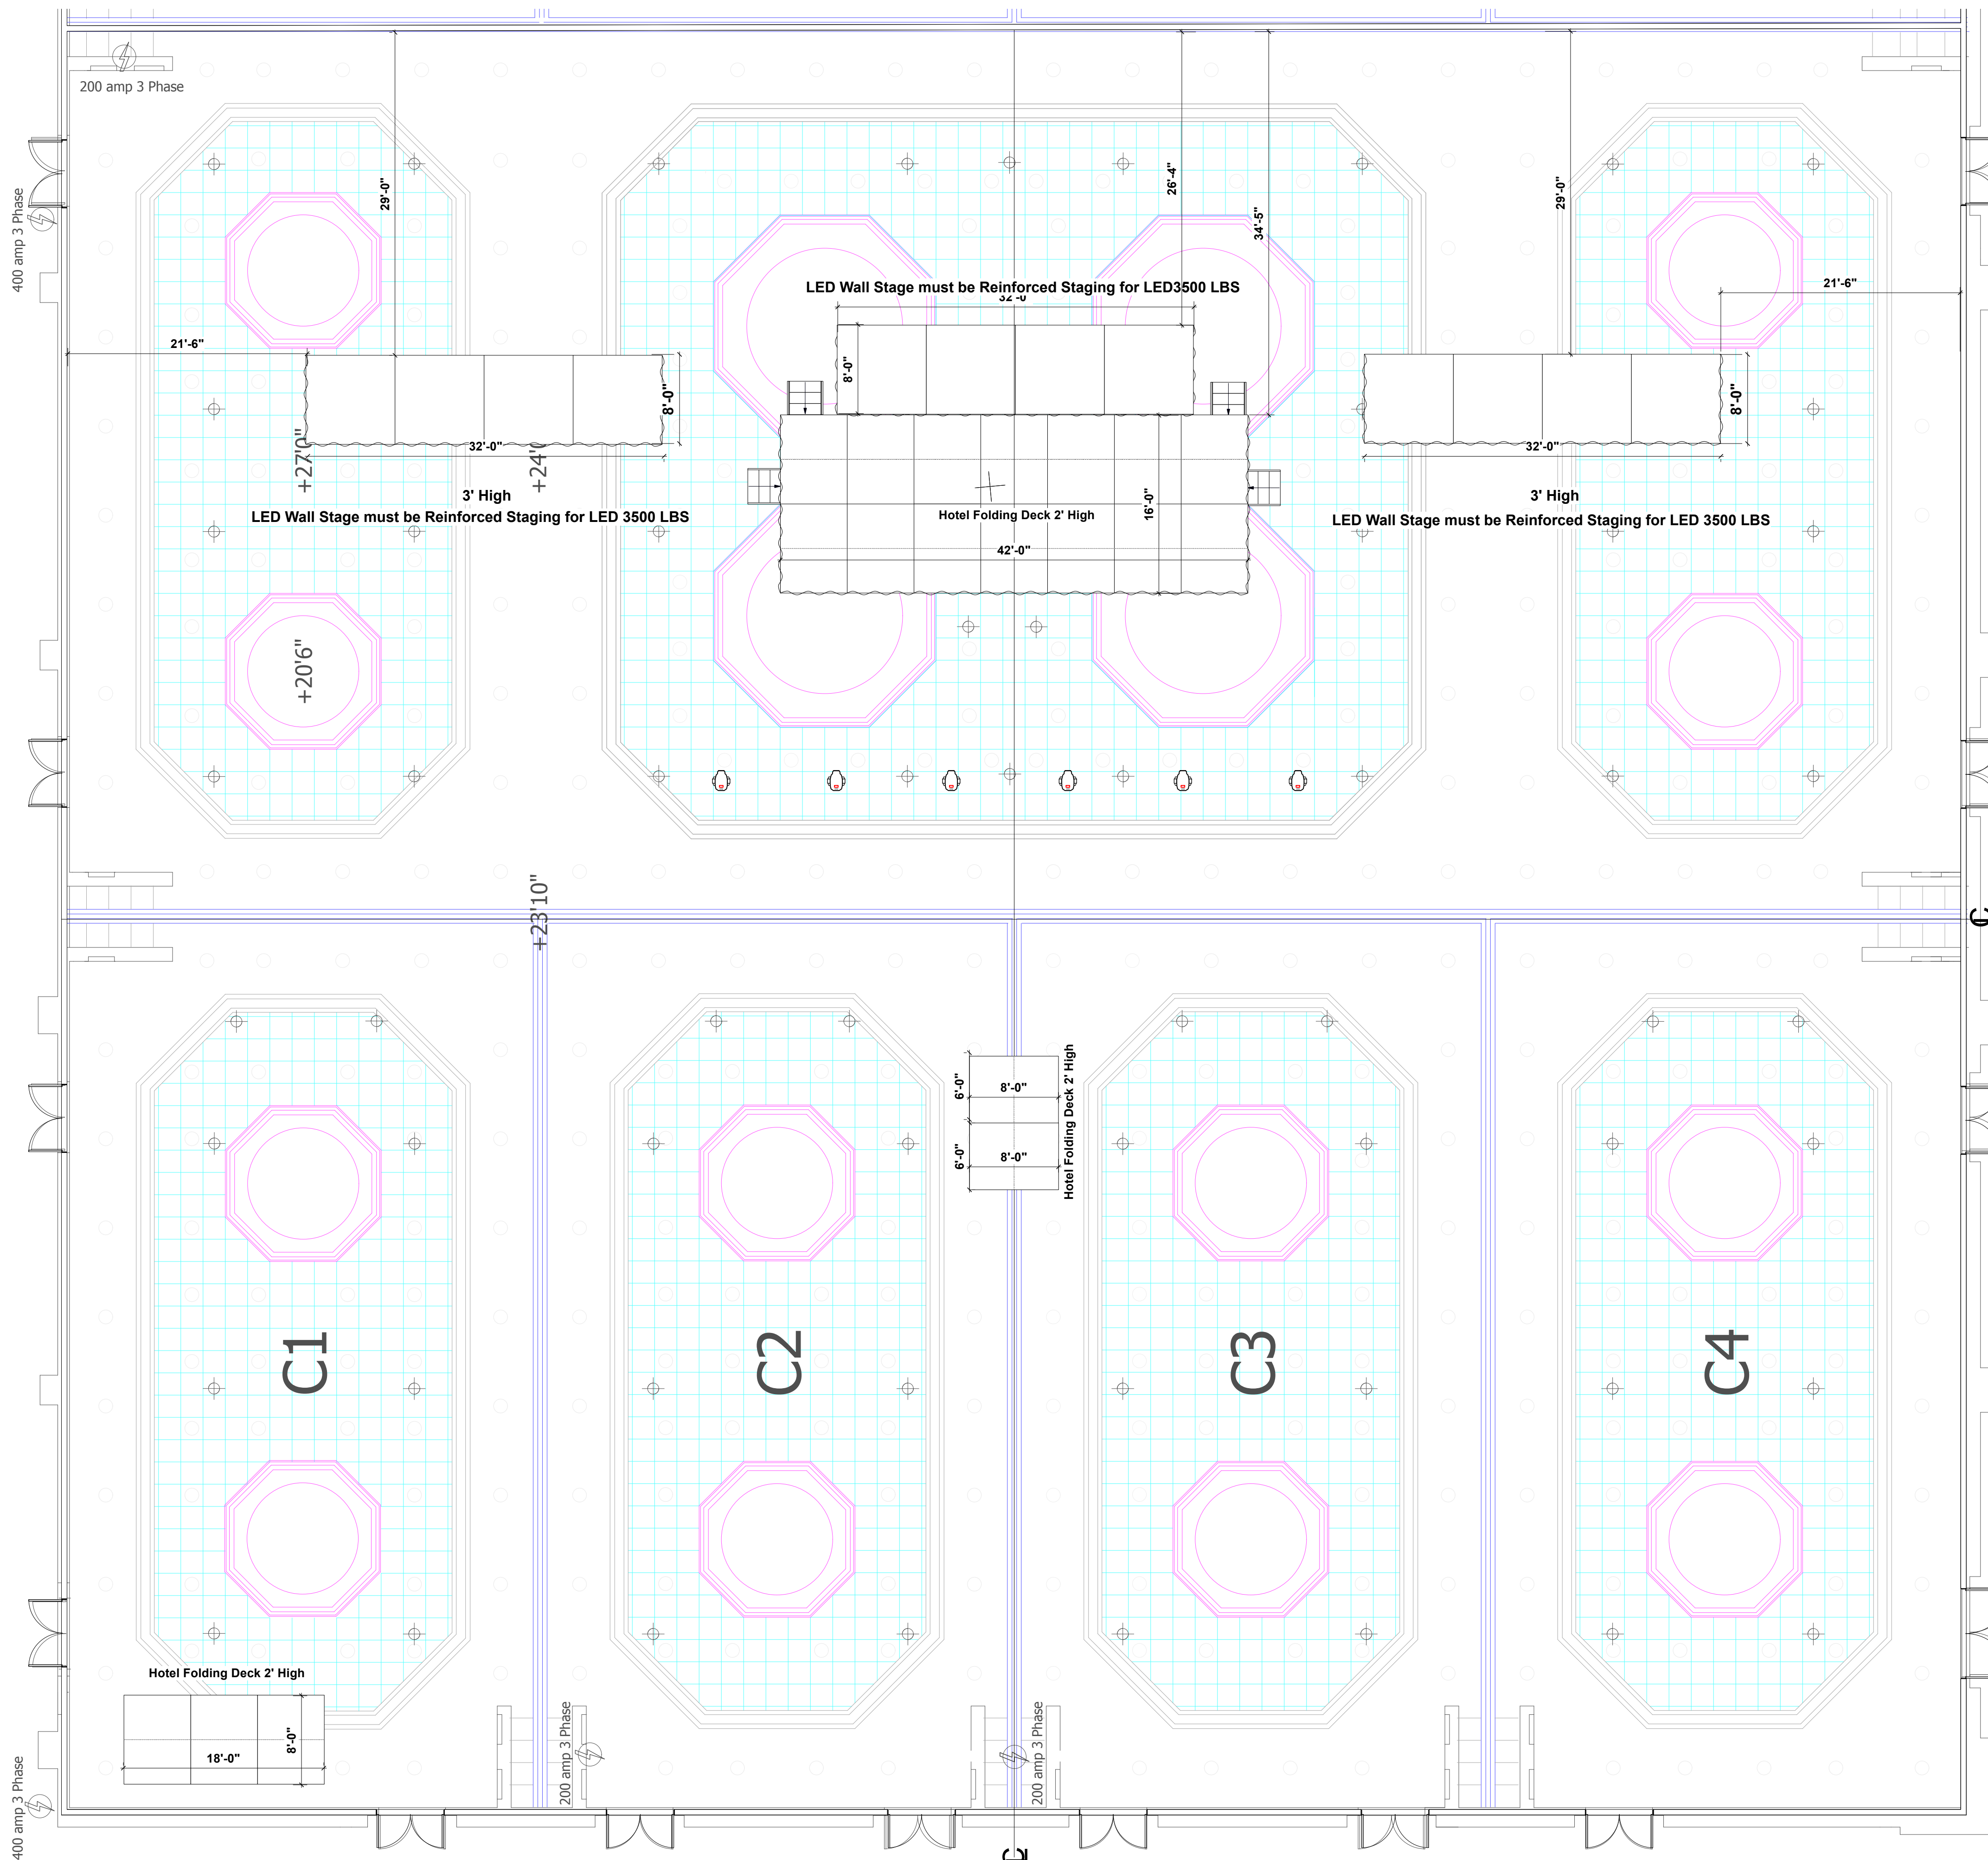

PREFUNCTION


1 Stage Dimensions
Scale: 1/8" = 1'-0"

OUTBACK MPS Conference

Stage Dimensions	Date : 6/17/26
Sheraton Dallas Lone Star Ballroom	Scale : 1/8" = 1'-0"
Technical Director : Chris Caiazzo	Sht-2
Executive Producer : Joe Mertz	



SERVICE HALLWAY

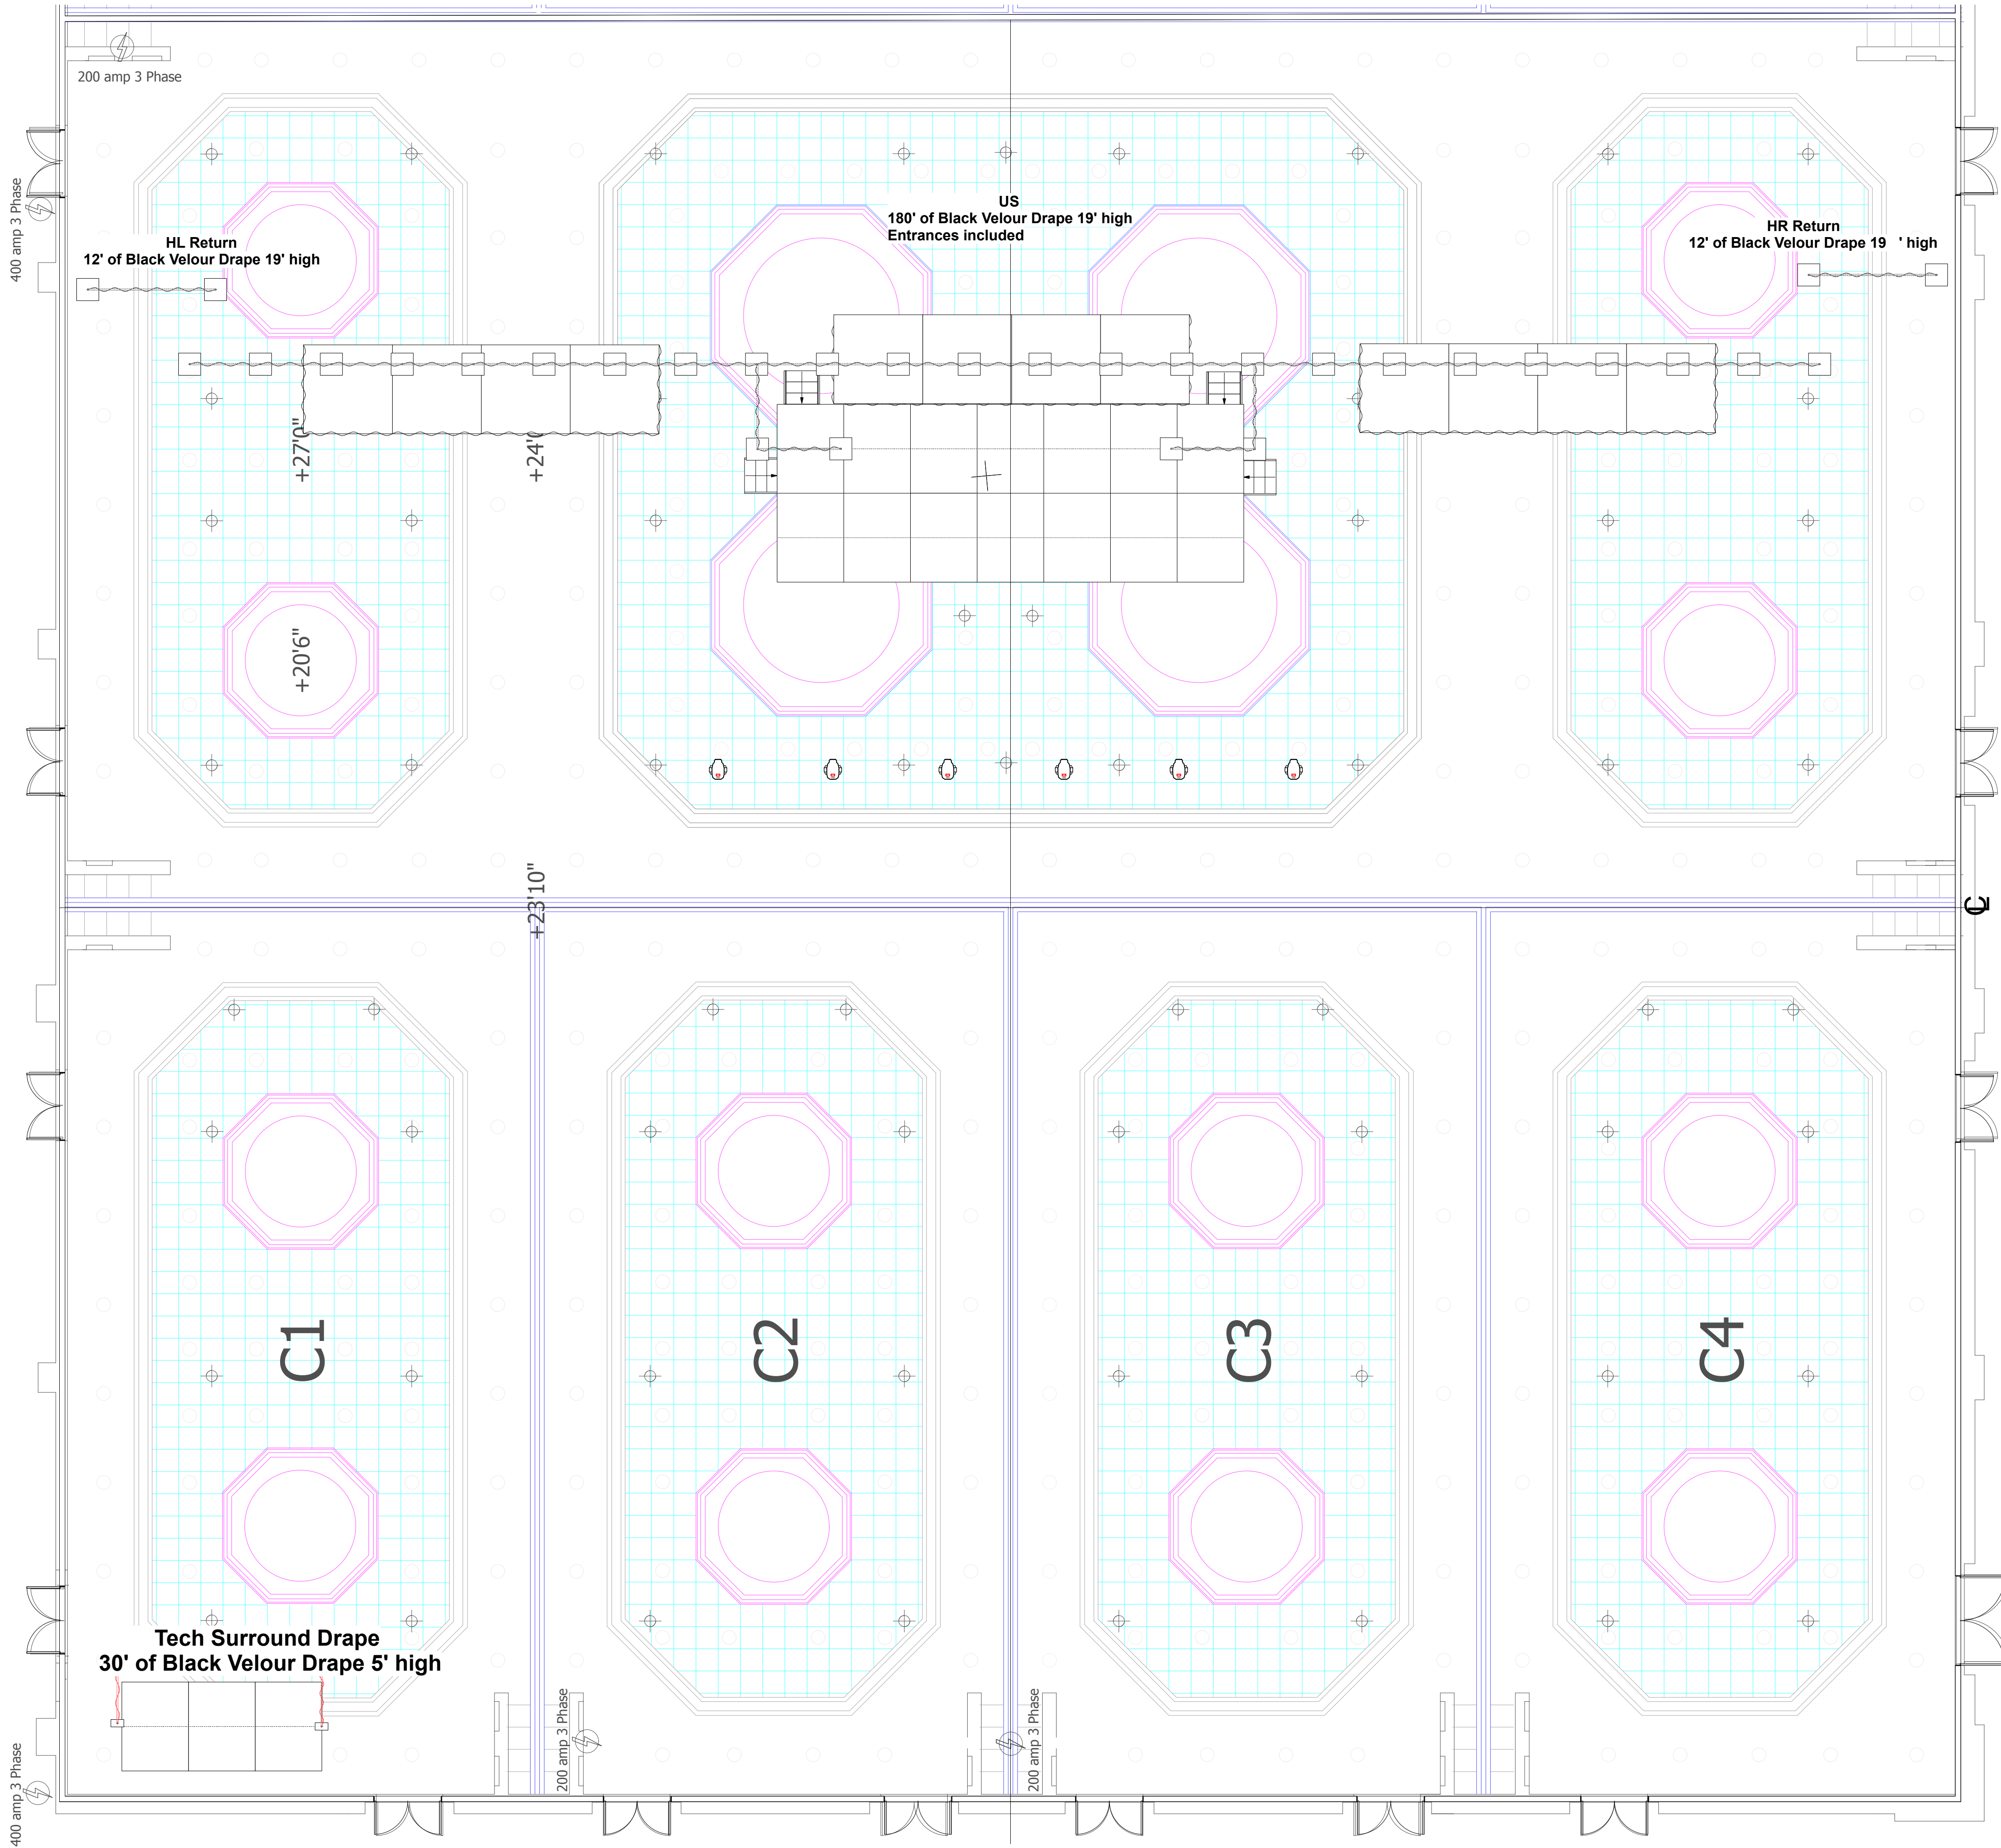

PREFUNCTION


1 Pipe And drape
Scale: 1/8" = 1'-0"

OUTBACK MPS Conference

Pipe and Drape	Date : 6/17/26
Sheraton Dallas Lone Star Ballroom	Scale : 1/8" = 1'-0"
Technical Director : Chris Caiazzo	Sht-3
Executive Producer : Joe Mertz	



SERVICE HALLWAY

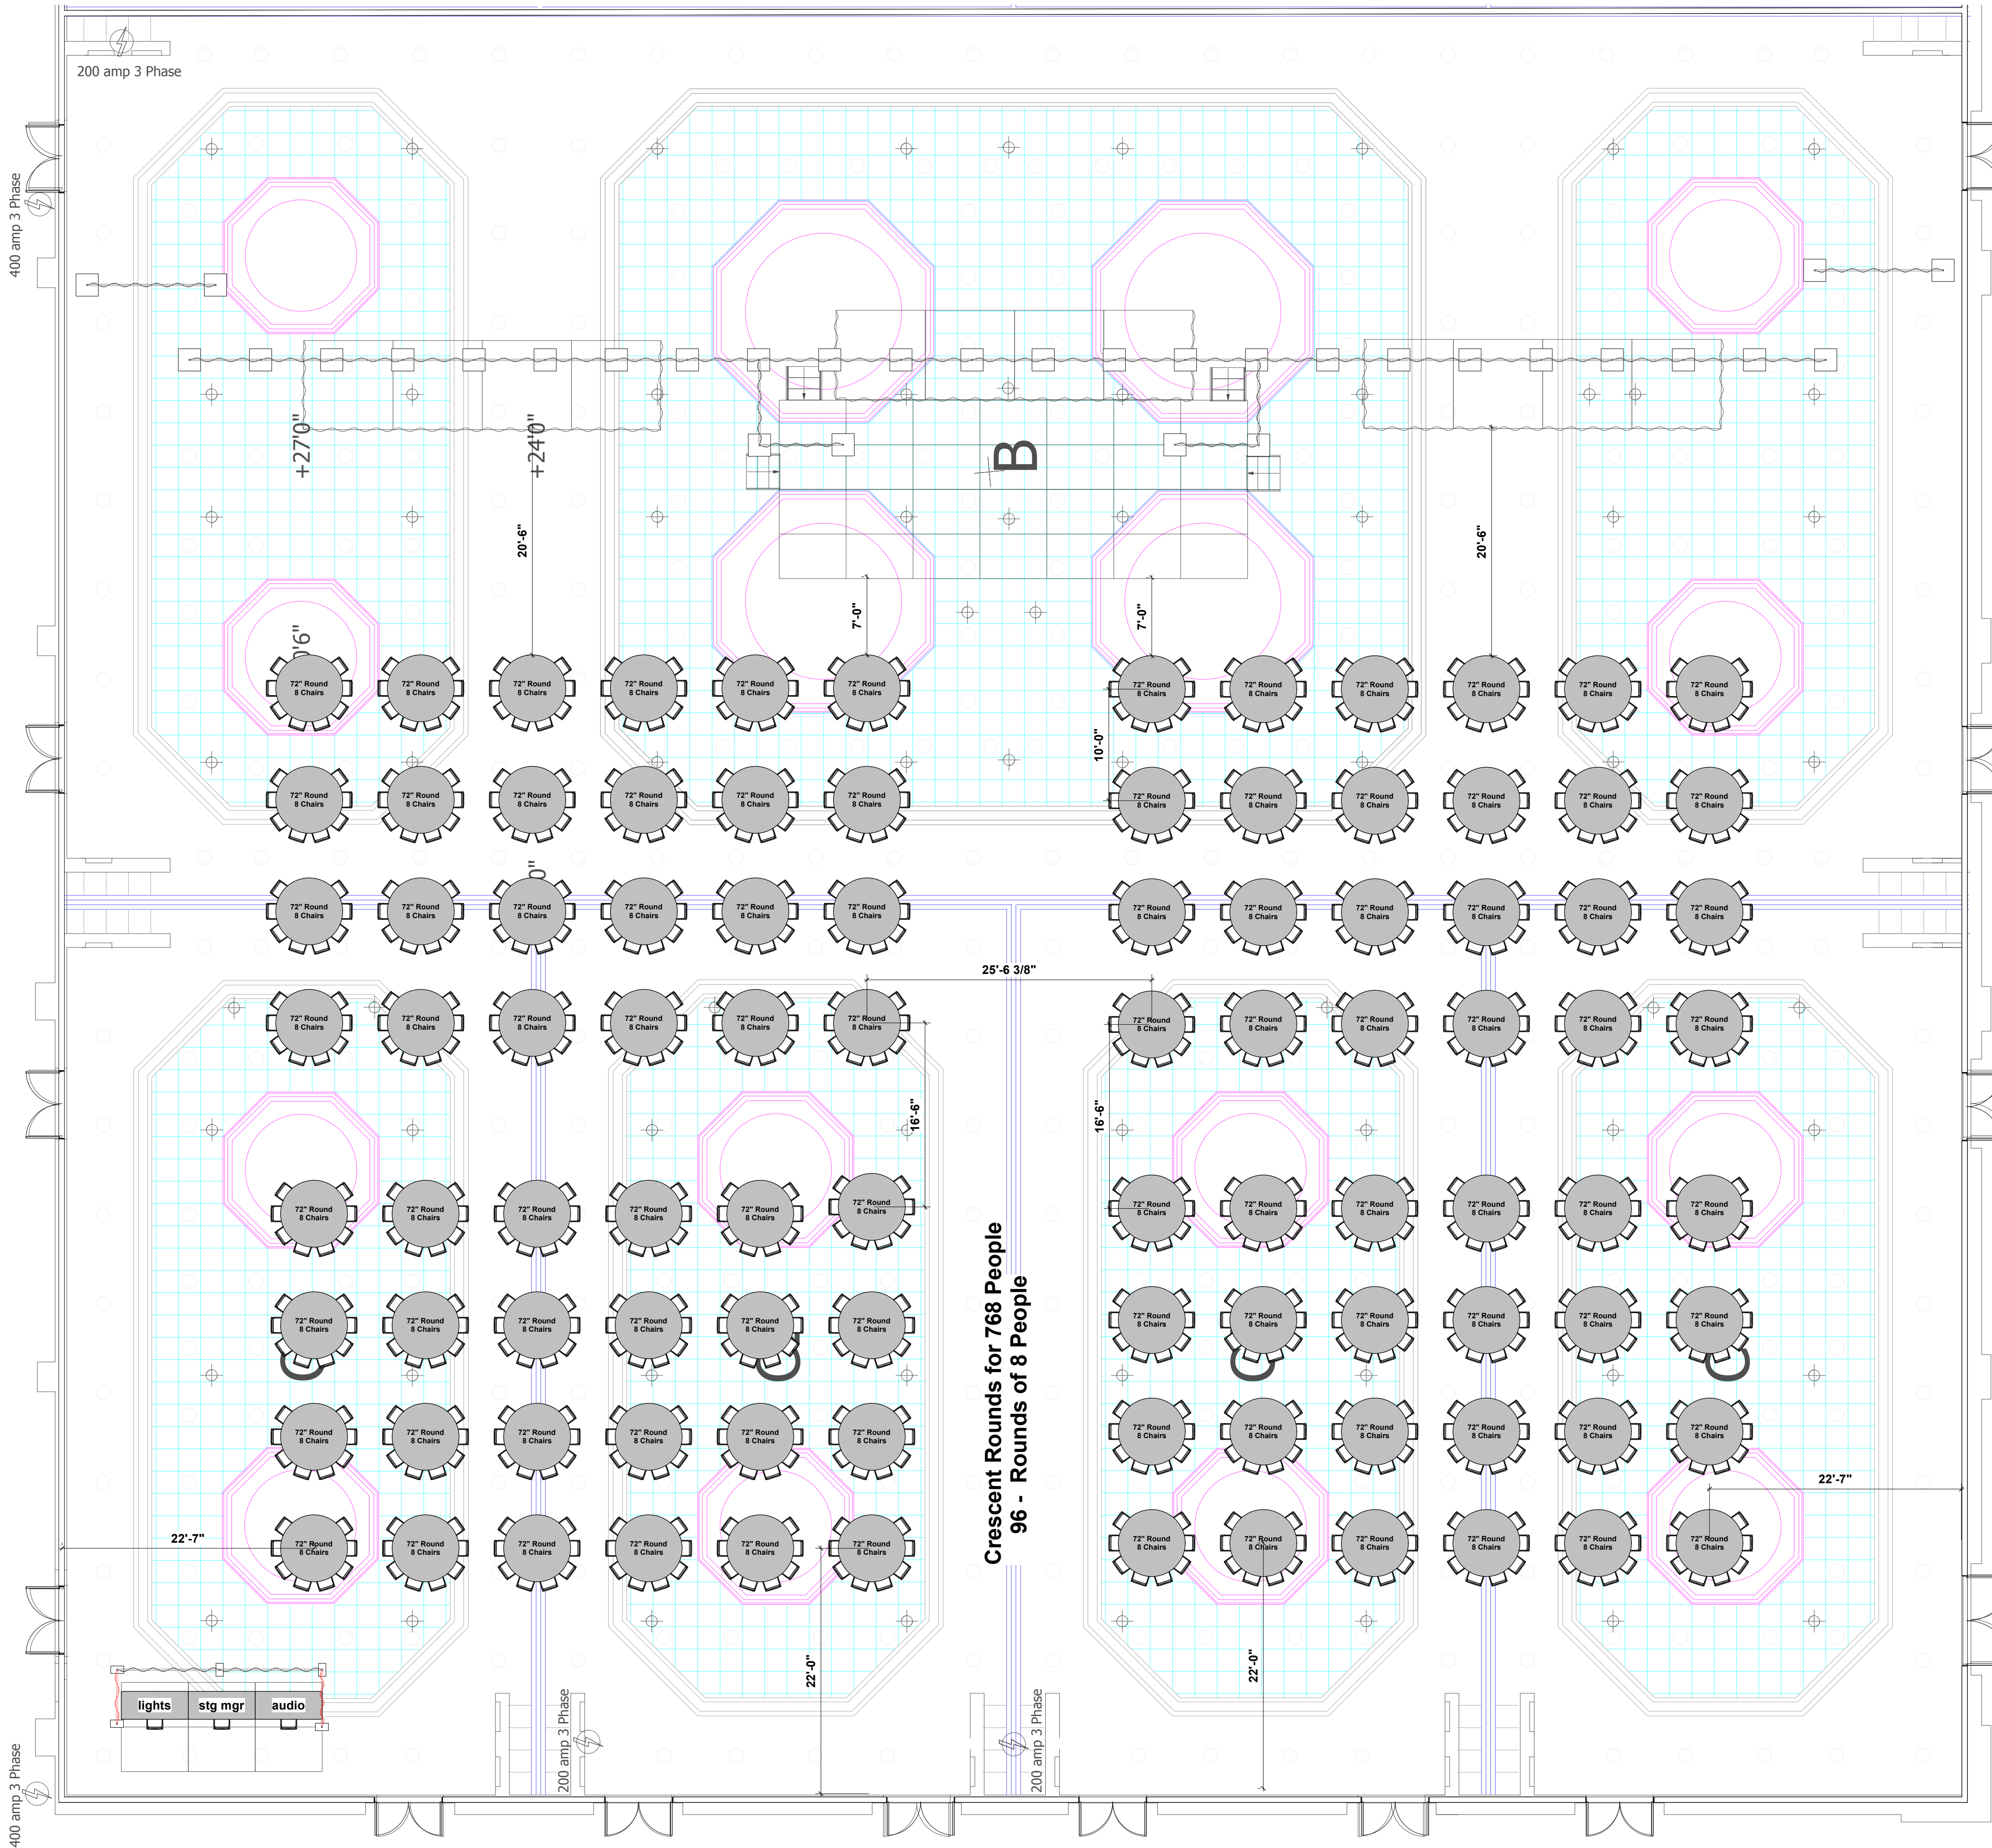

PREFUNCTION


1 Crescent rounds
Scale: 1/8" = 1'-0"

OUTBACK MPS Conference

Seating	Date : 6/17/26
Sheraton Dallas Lone Star Ballroom	Scale : 1/8" = 1'-0"
Technical Director : Chris Caiazzo	Sht-4 OF 9
Executive Producer : Joe Mertz	

SERVICE HALLWAY


PREFUNCTION

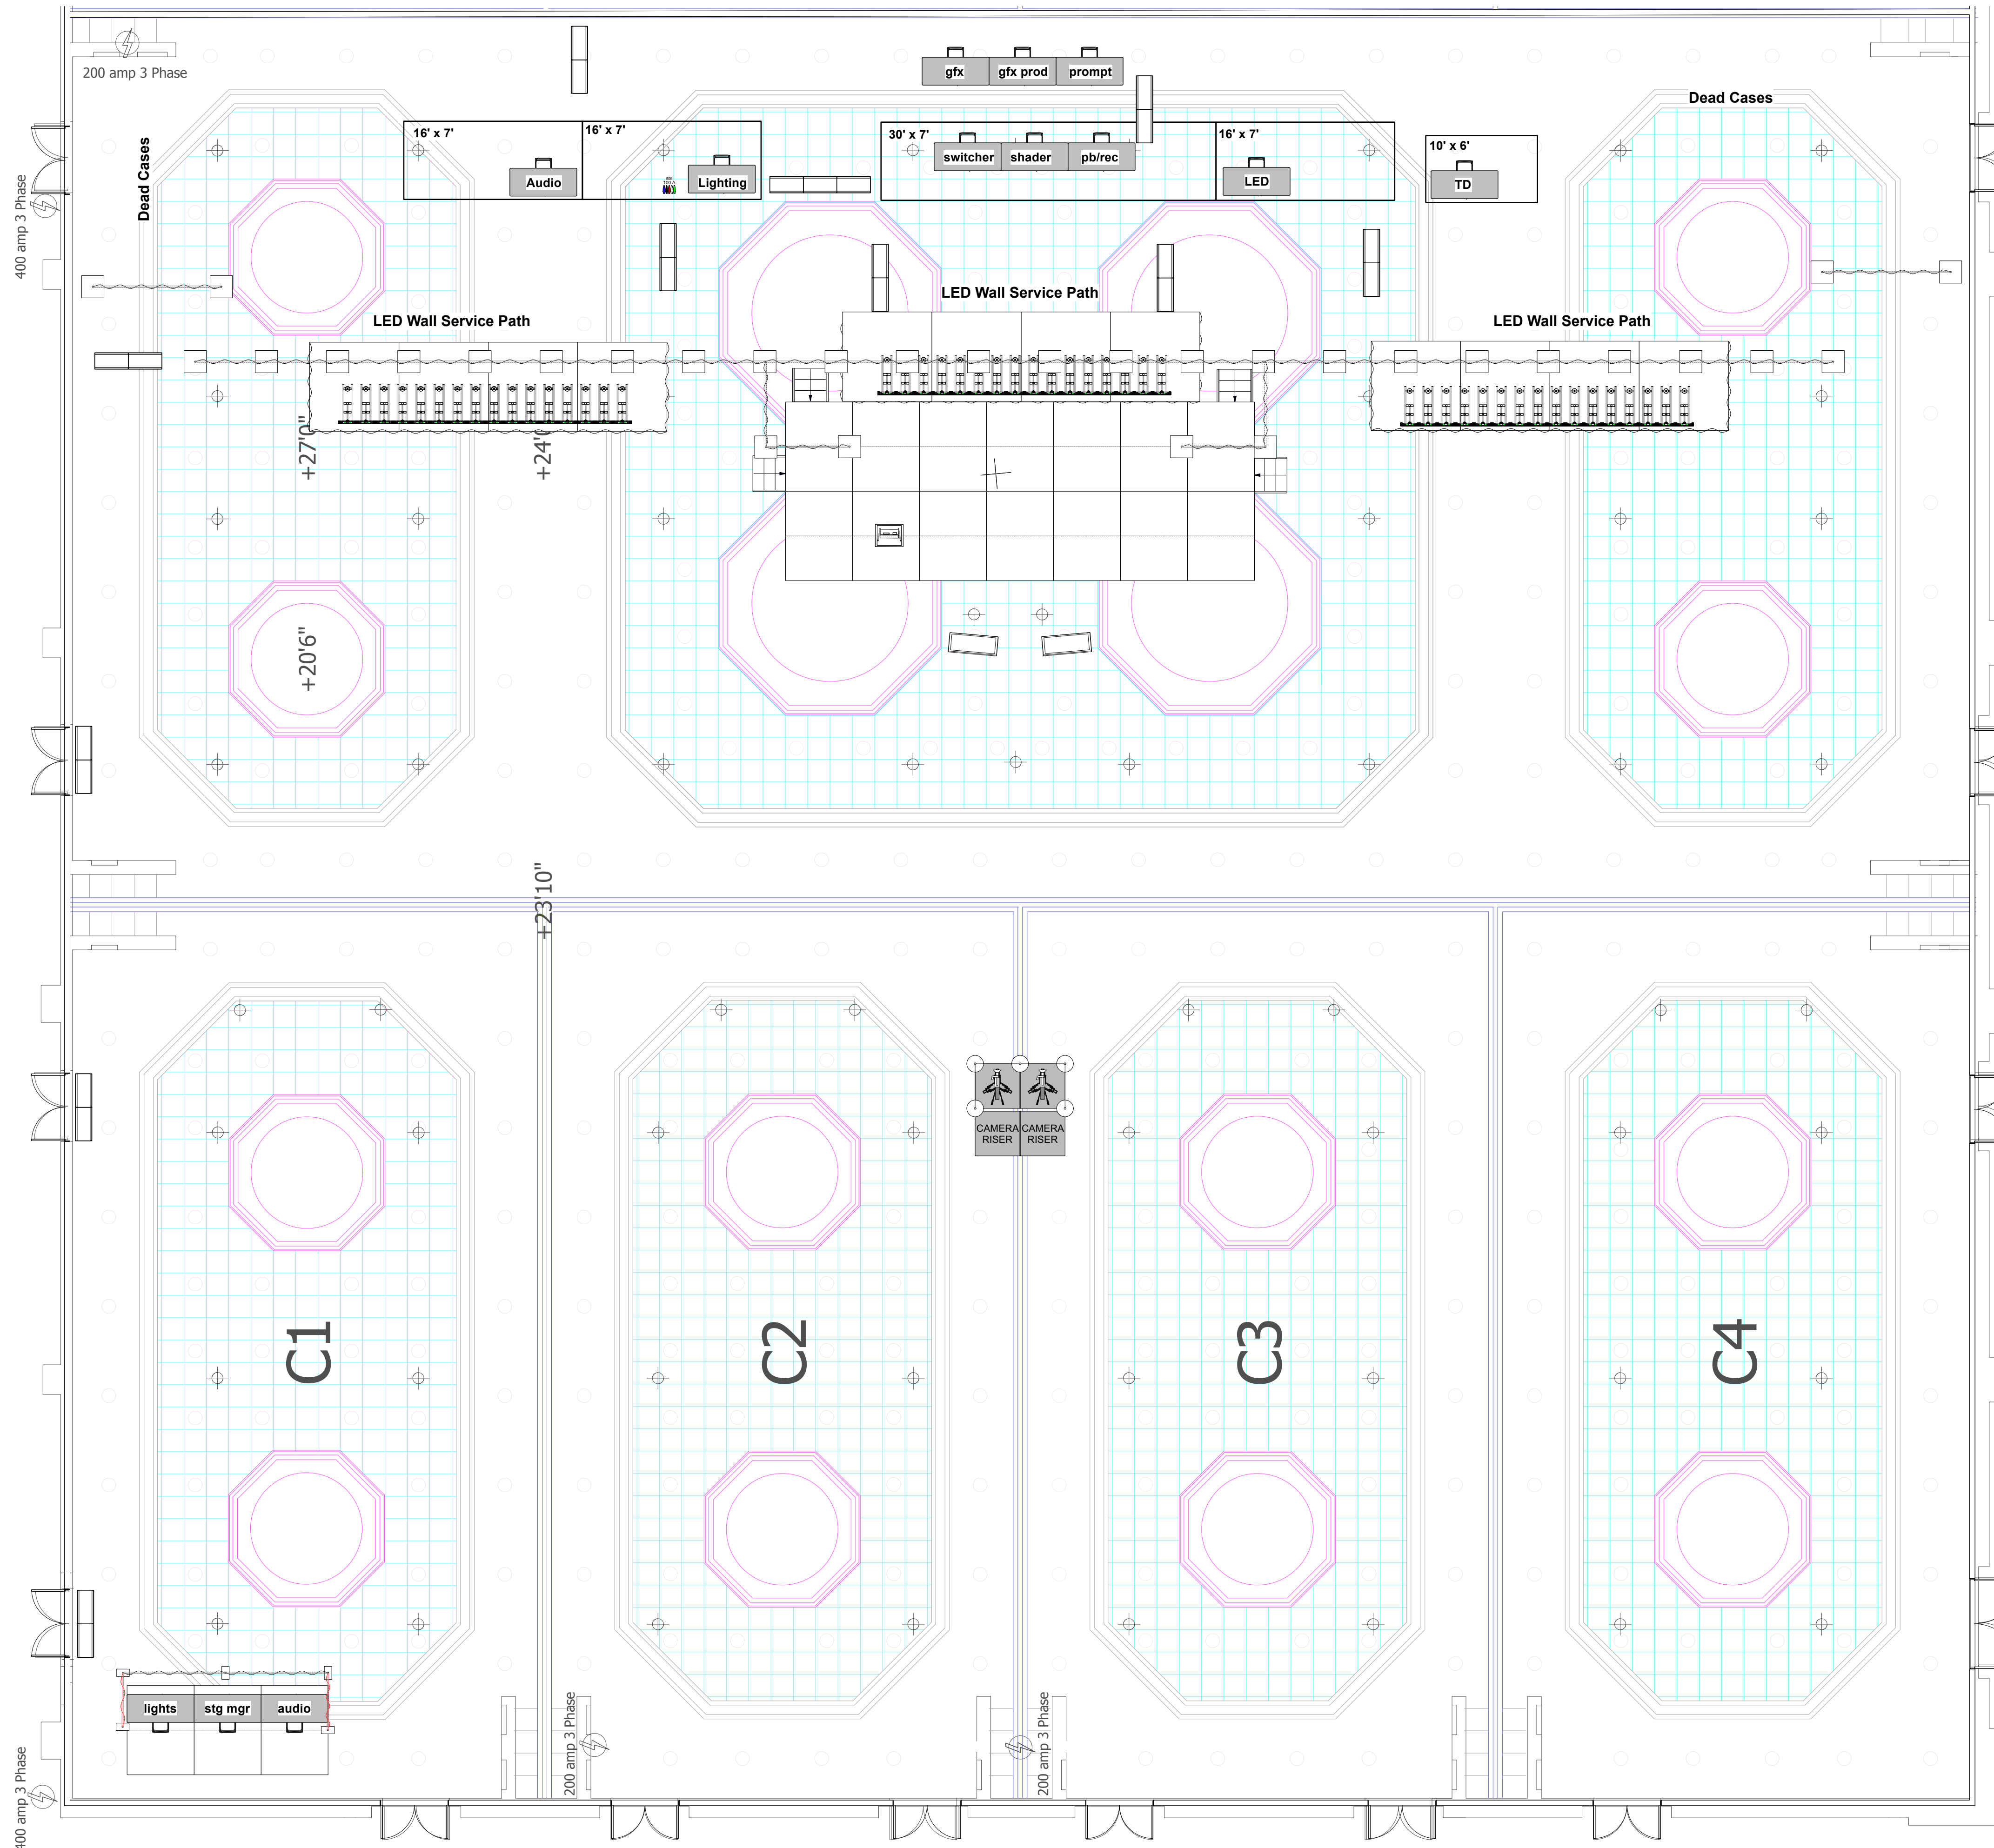

1
Video
Scale: 1/8" = 1'-0"

OUTBACK MPS Conference	
Video Plan	Date : 6/17/26
Sheraton Dallas Lone Star Ballroom	Scale : 1/8" = 1'-0"
Technical Director : Chris Caiazza	Sht-5
Executive Producer : Joe Mertz	
OF	
9	

SERVICE HALLWAY

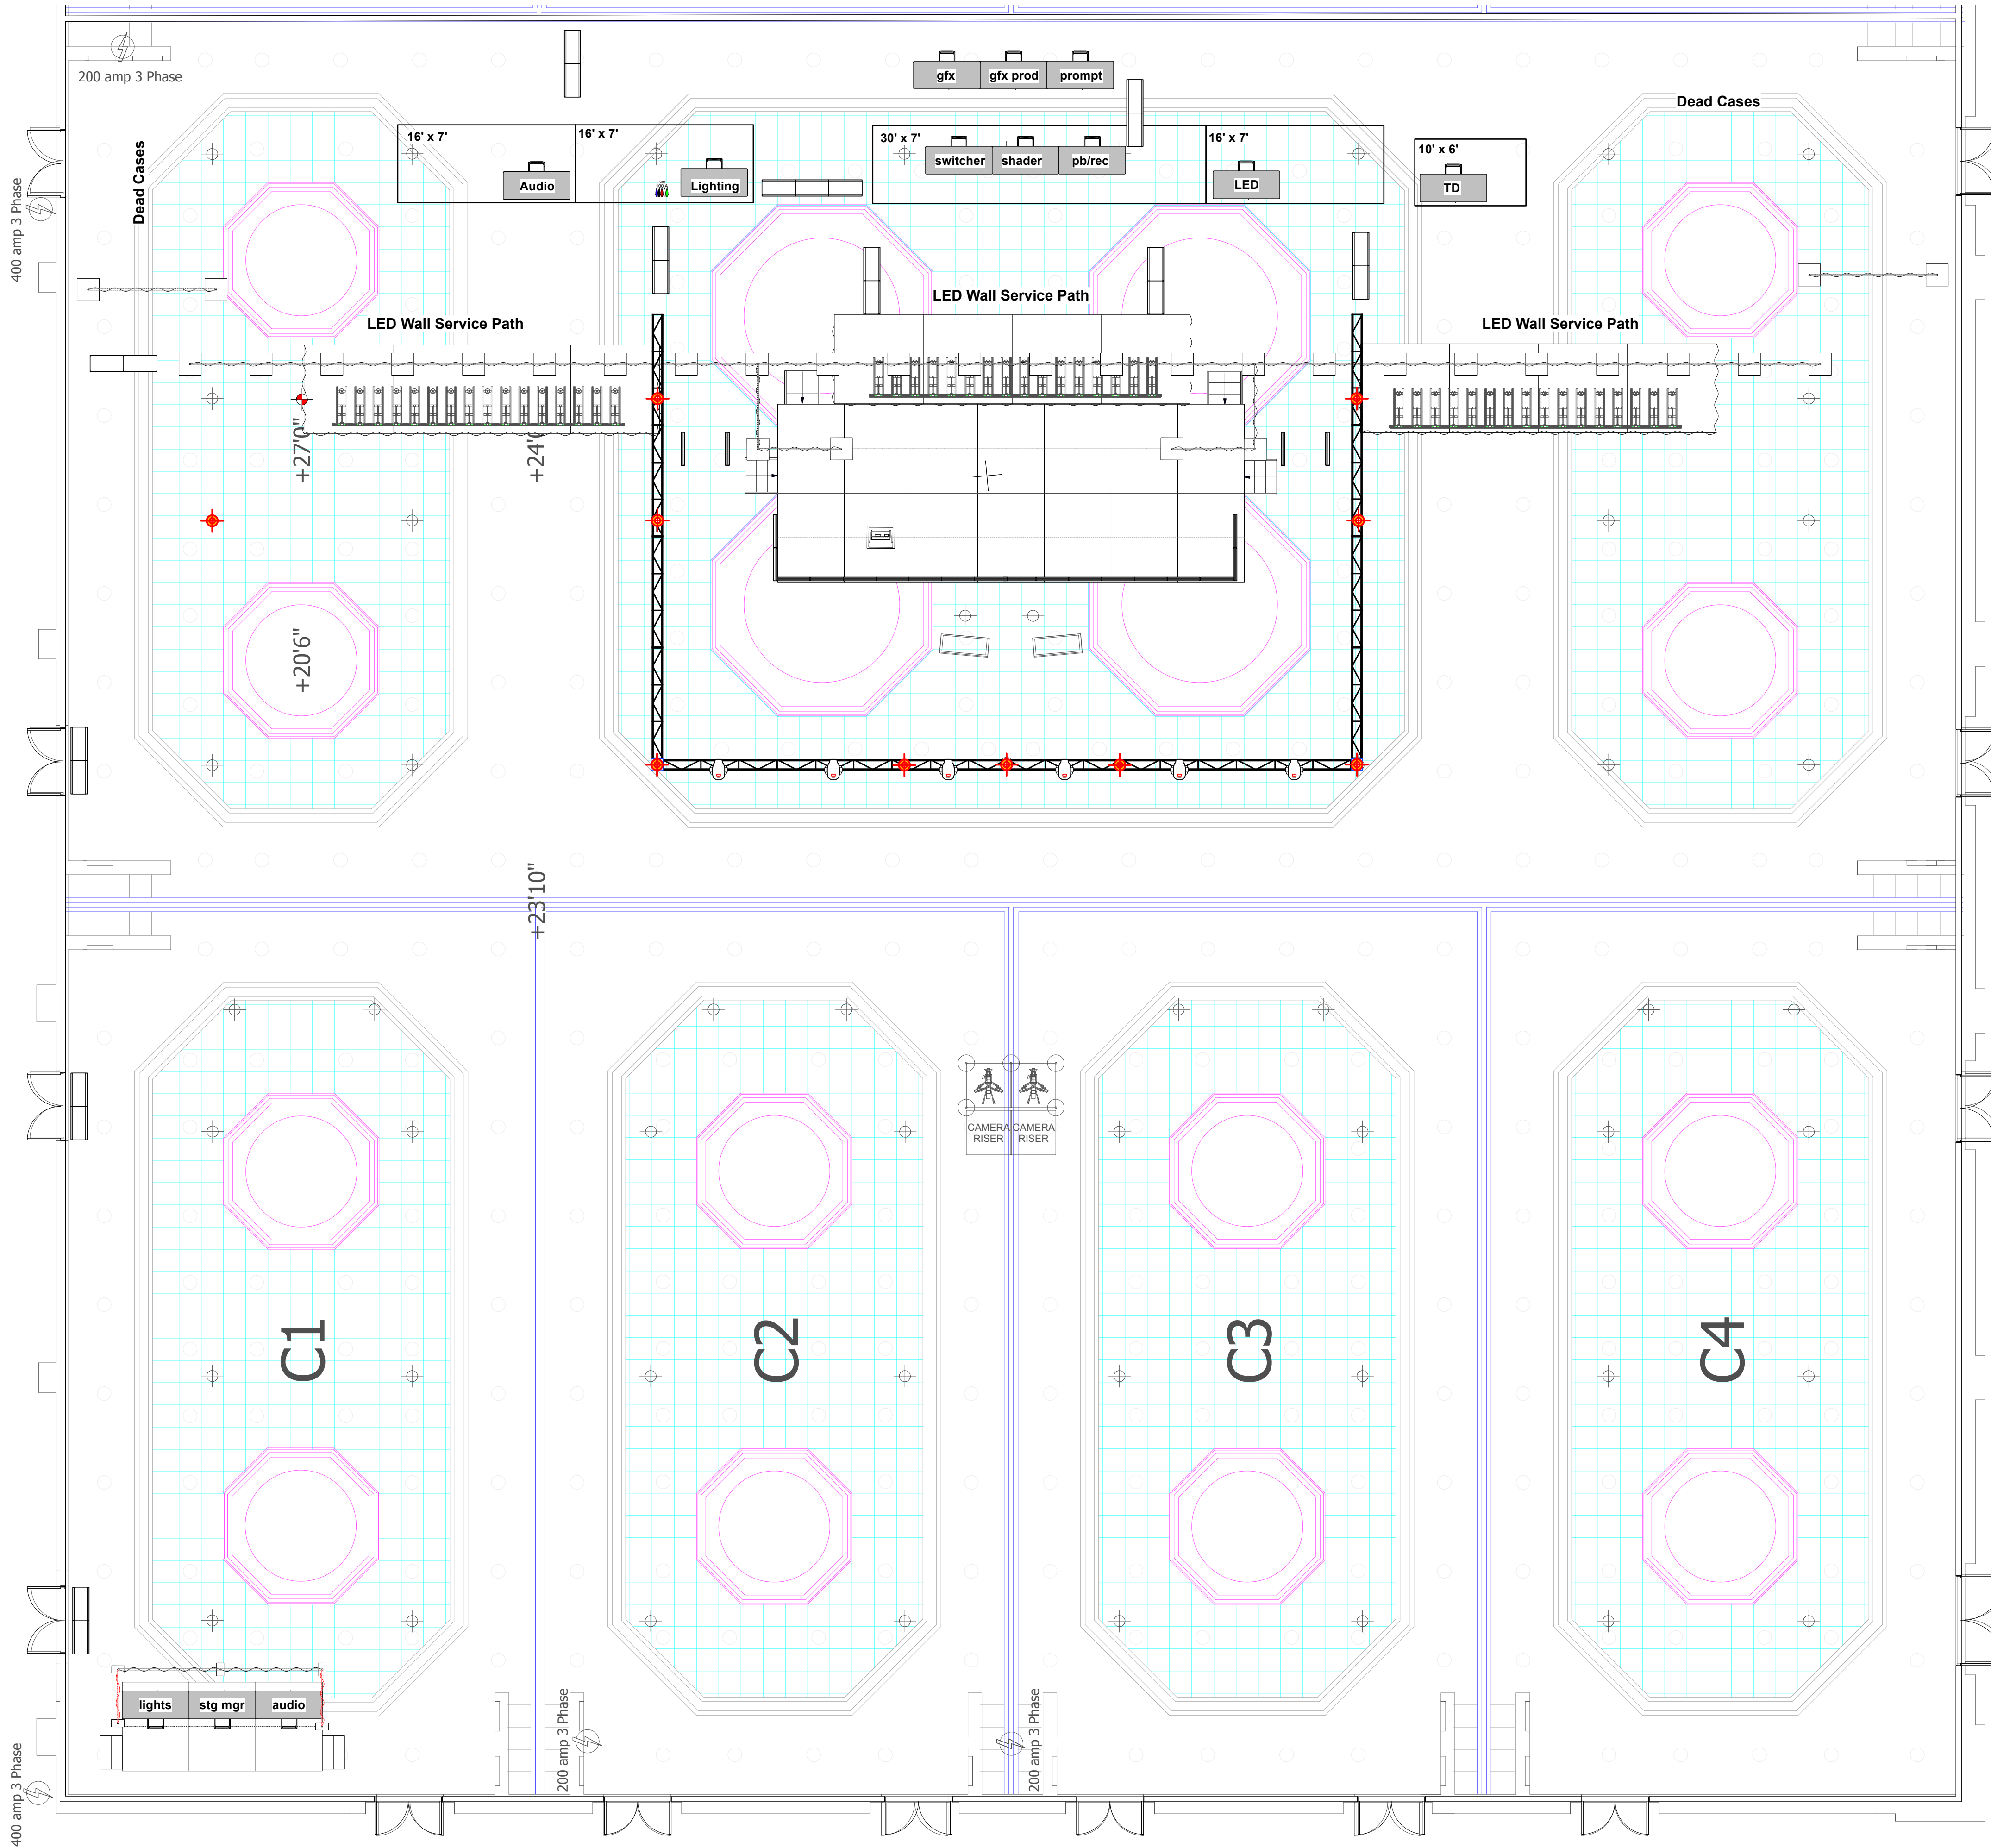

PREFUNCTION


1 Lighting
 Scale: 1/8" = 1'-0"

OUTBACK MPS Conference


Lighting Plan	Date : 6/17/26
Sheraton Dallas Lone Star Ballroom	Scale : 1/8" = 1'-0"
Technical Director : Chris Caiazza	Sht-6
Executive Producer : Joe Mertz	
OF	
9	



1 ISO
Scale: 3/16" = 1'-0"

OUTBACK MPS Conference	
Right ISO	Date : 6/17/26
Sheraton Dallas Lone Star Ballroom	Scale : 3/16" = 1'-0"
Technical Director : Chris Caiazza	Sht-7
Executive Producer : Joe Mertz	
OF	
9	
	

SERVICE HALLWAY

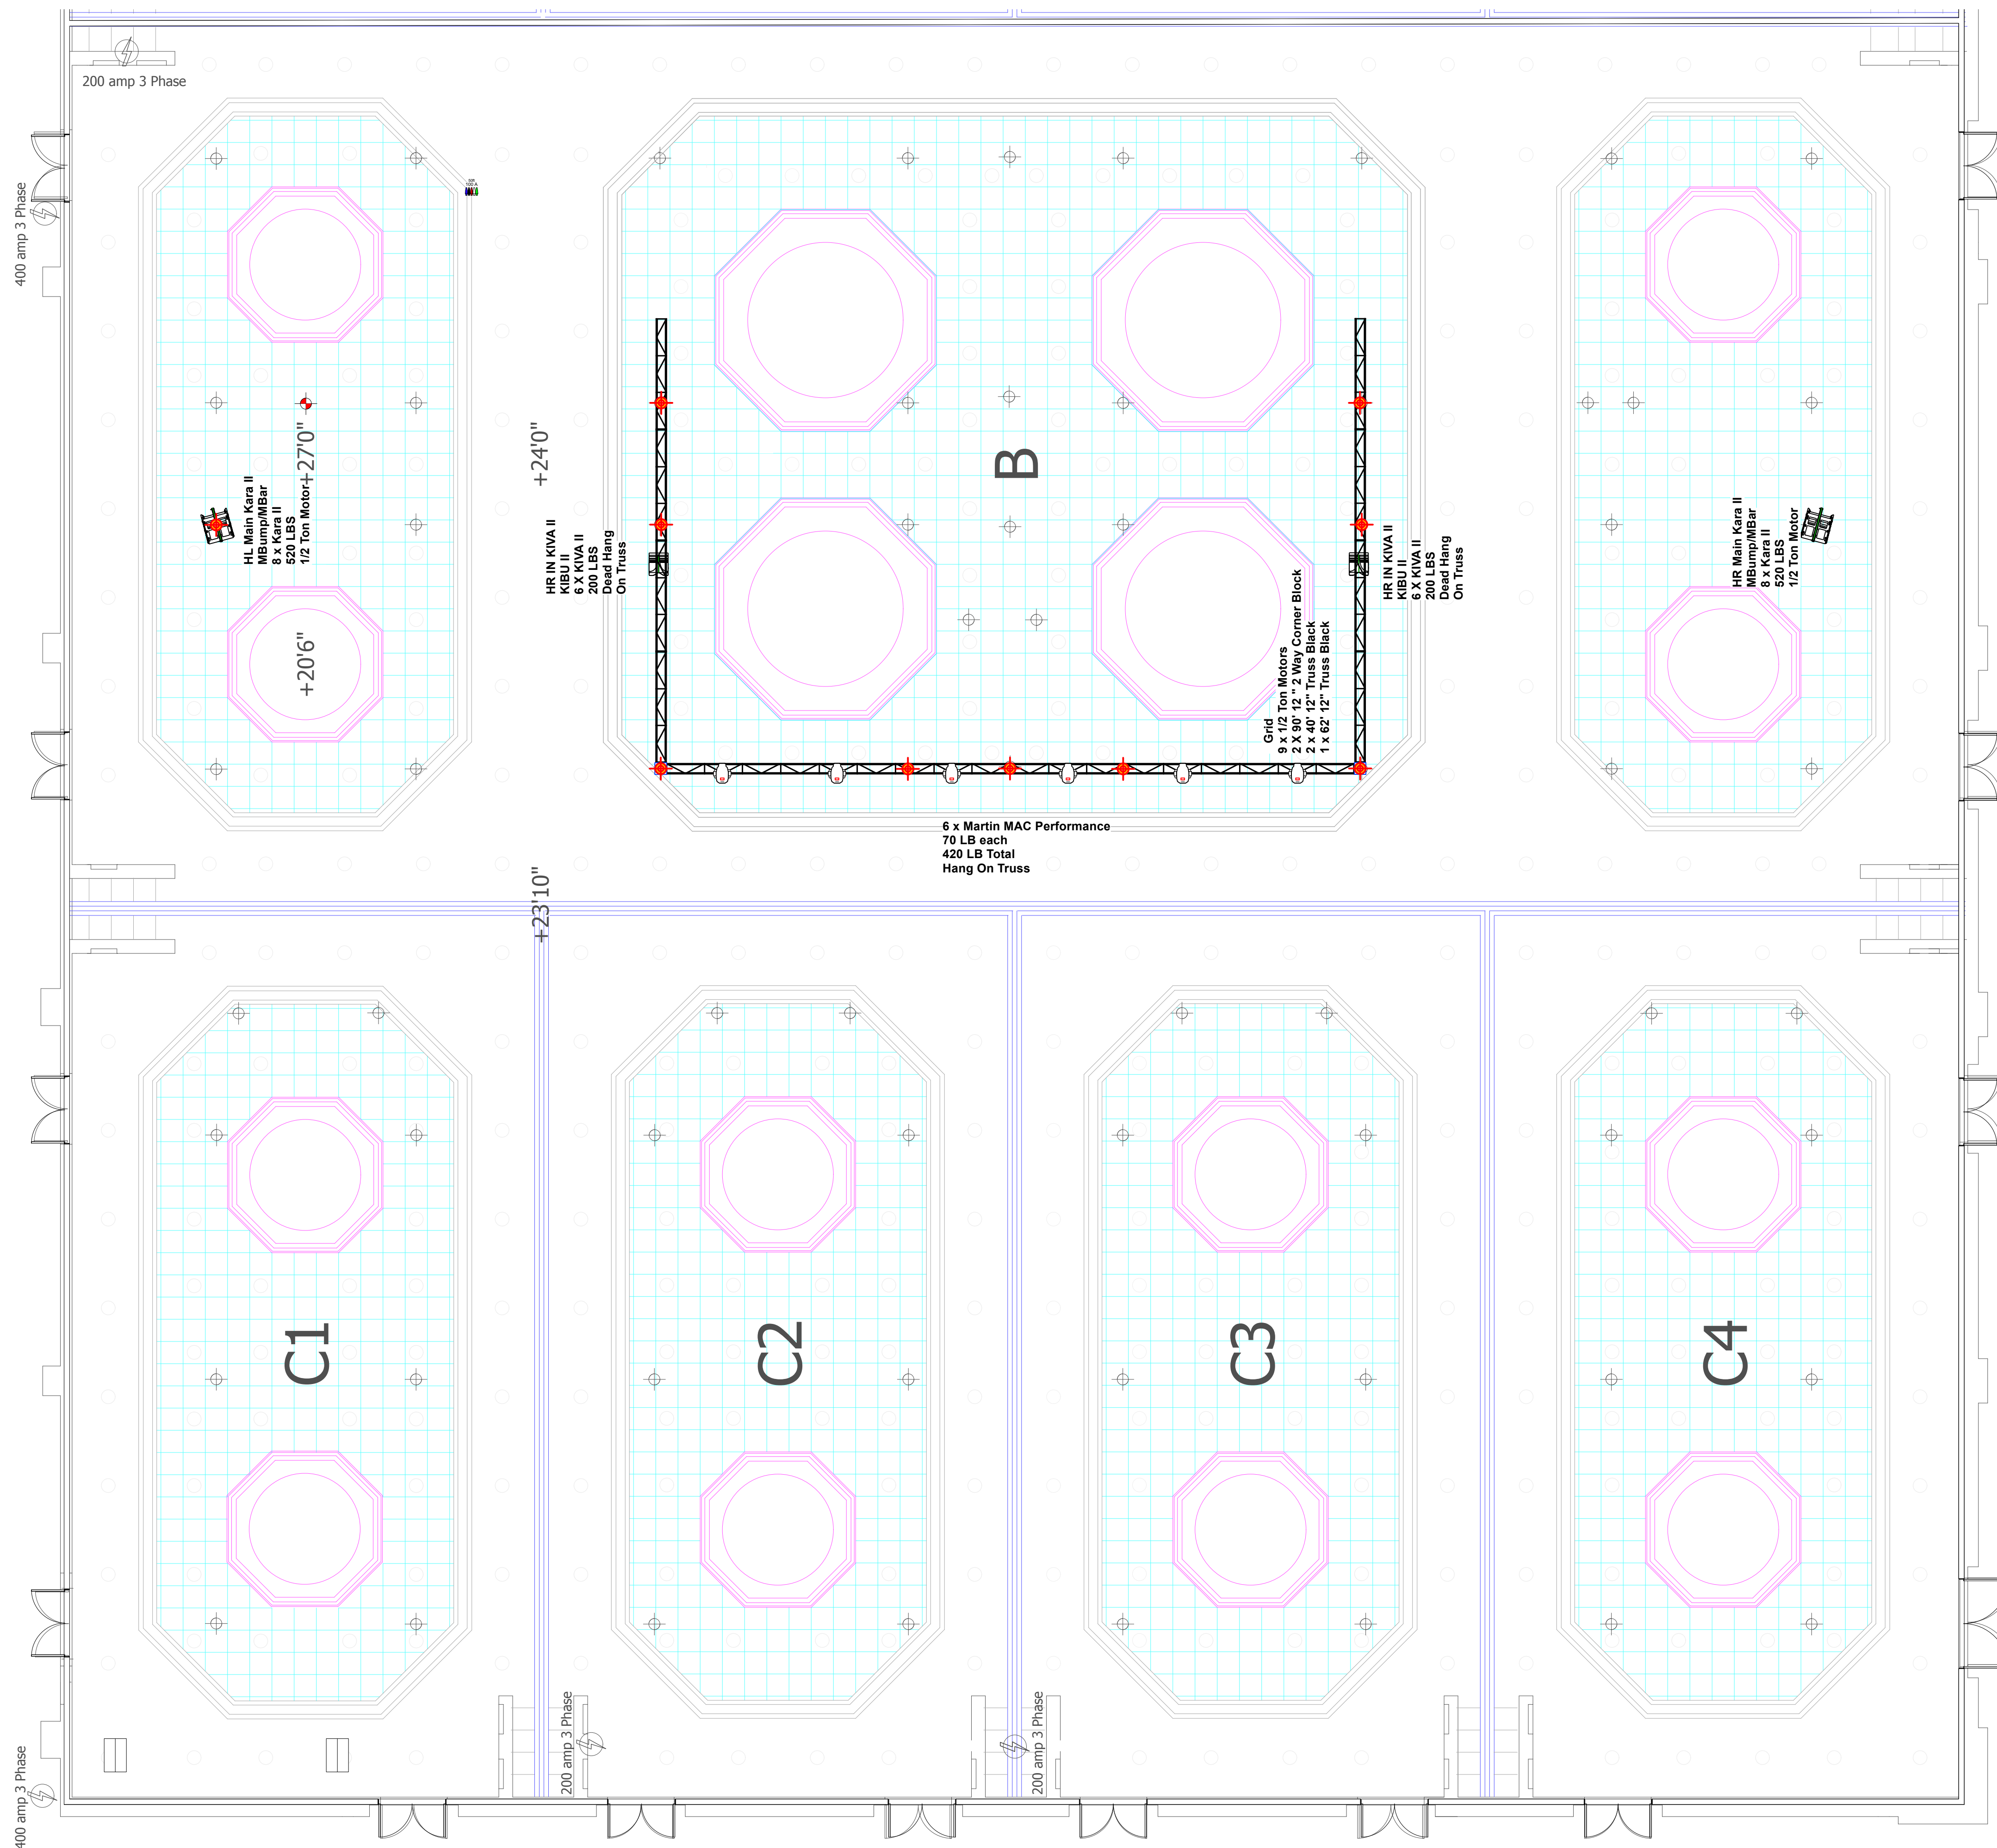

PREFUNCTION


1 igging
Scale: 1/8" = 1'-0"

OUTBACK MPS Conference

Rigging	Date : 6/18/26
Sheraton Dallas Lone Star Ballroom	Scale : 1/8" = 1'-0"
Technical Director : Chris Caiazza	Sht-8 OF 9
Executive Producer : Joe Mertz	

SERVICE HALLWAY

PREFUNCTION

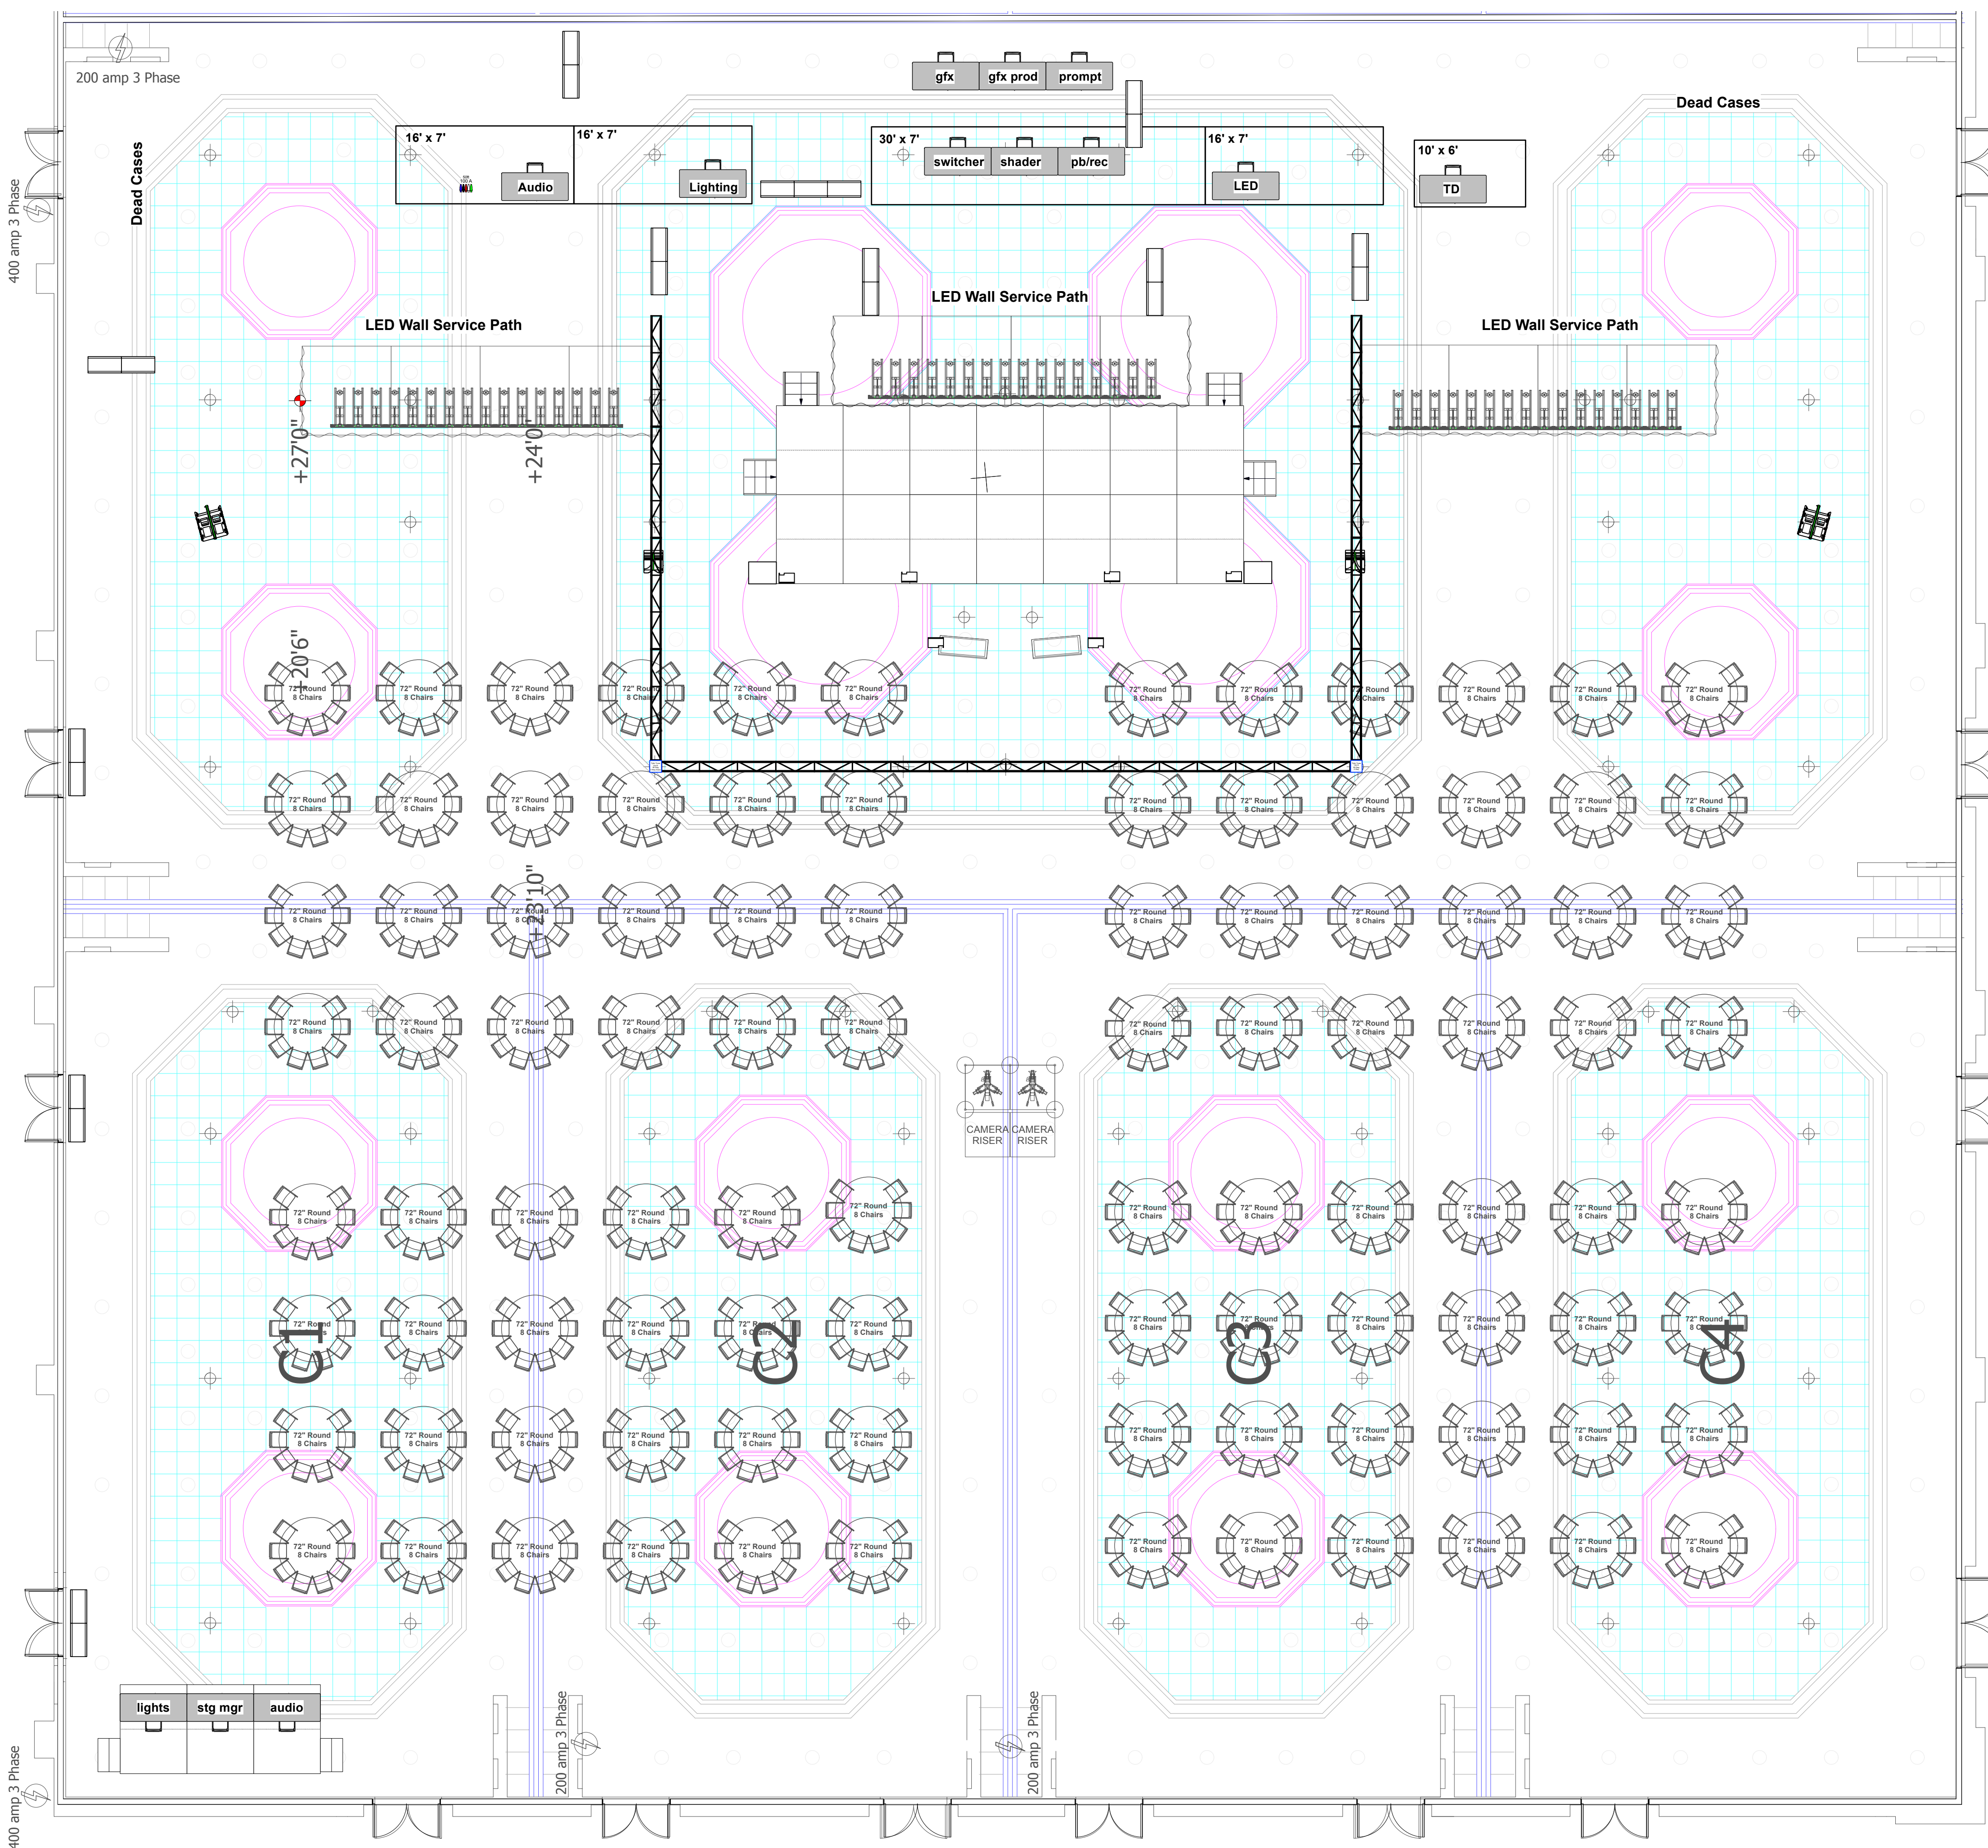

1 Audio
Scale: 1/8" = 1'-0"

OUTBACK MPS Conference

Audio	Date : 6/18/26
Sheraton Dallas Lone Star Ballroom	Scale : 1/8" = 1'-0"
Technical Director : Chris Caiazza	Sht-9 OF 9
Executive Producer : Joe Mertz	